


1

HEATING PLANT - BASEMENT LEVEL


SCALE: 3/32" = 1'

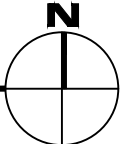

Apr 27, 2012 - 4:05pm - 303_A1.dwg
H:\Heating Plant\Building Plan - Book Copy\

M MONTANA STATE UNIVERSITY
FACILITIES PLANNING,
DESIGN & CONSTRUCTION
BOZEMAN, MONTANA
PHONE: 406.994.4131 FAX: 406.994.6572

INDEX #	5
BUILDING #	303

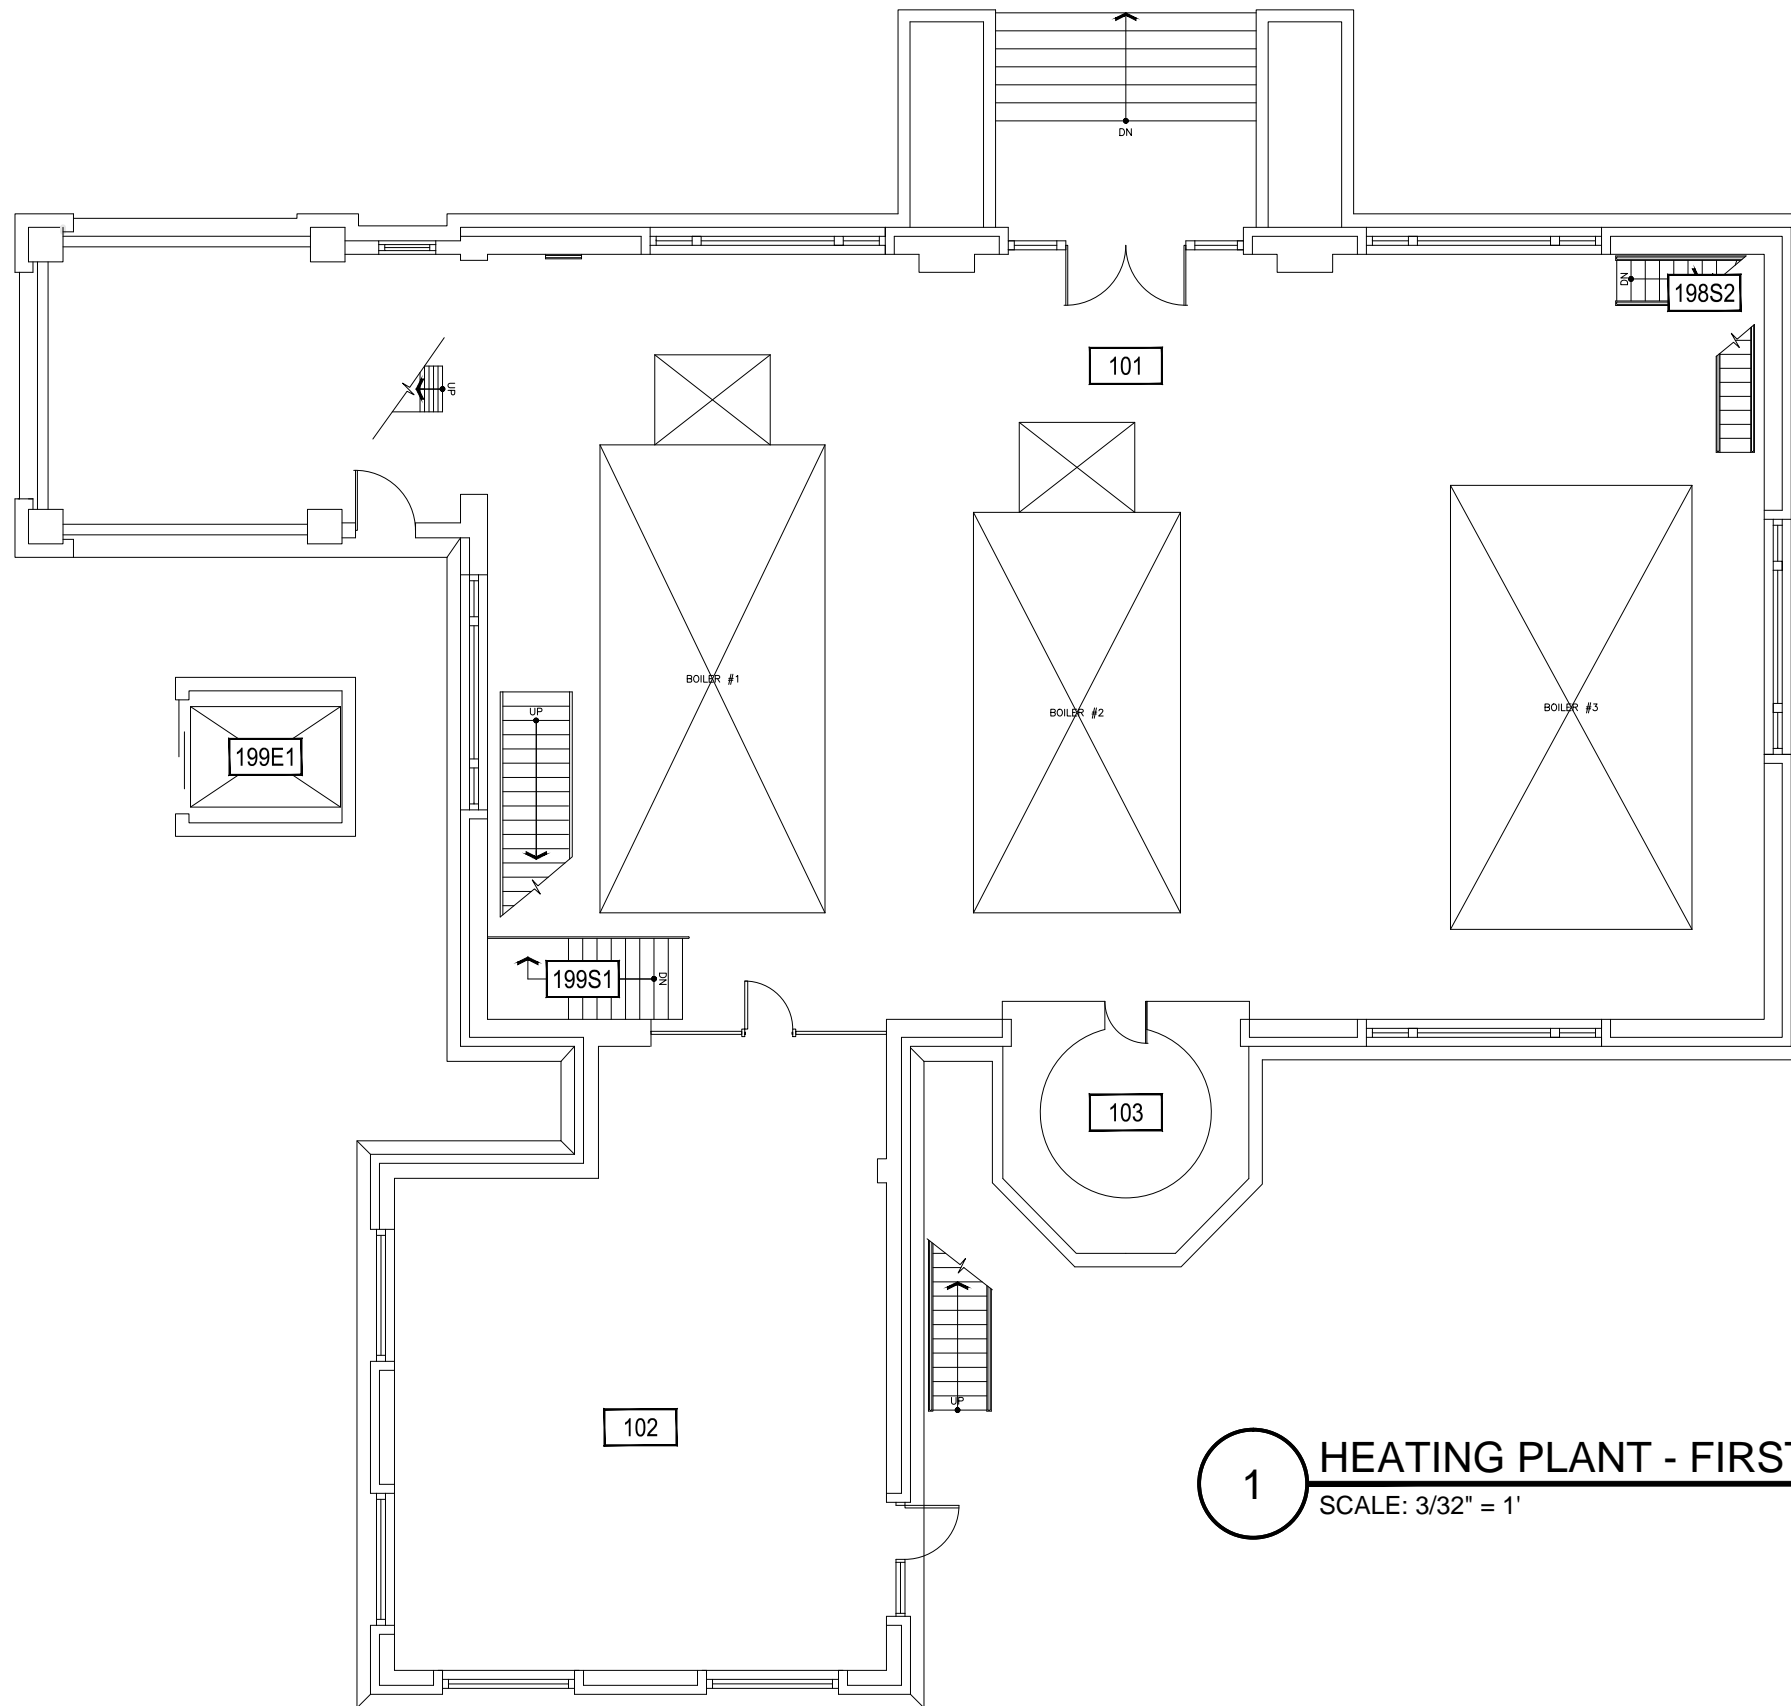


1

HEATING PLANT - FIRST LEVEL

SCALE: 3/32" = 1'



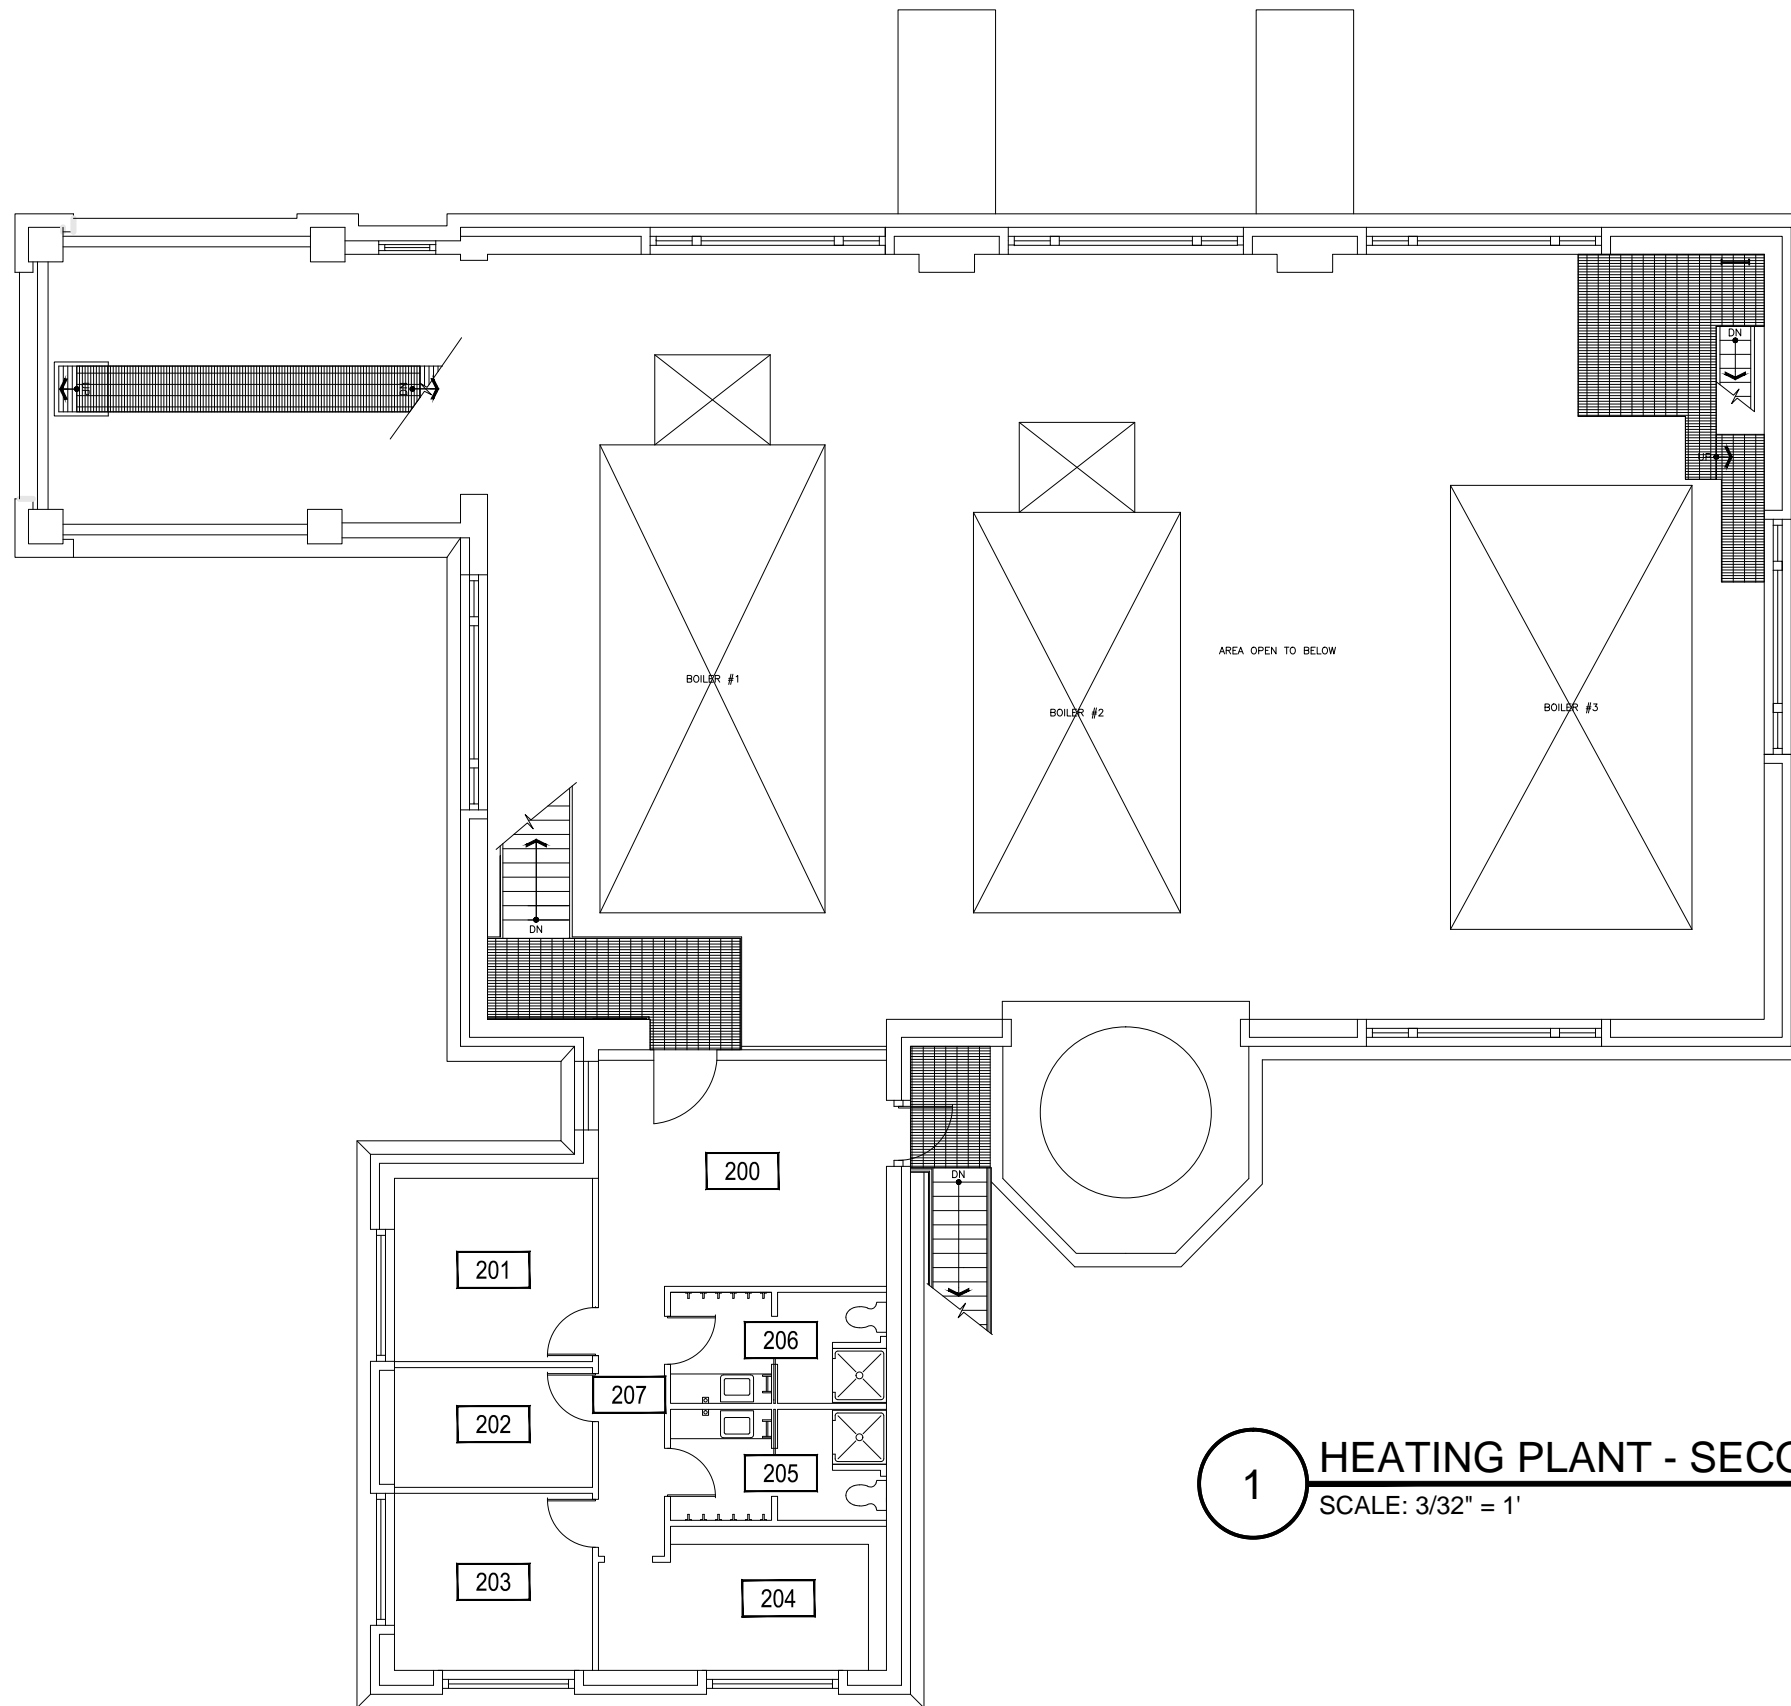

1

HEATING PLANT - SECOND LEVEL

SCALE: 3/32" = 1'




Apr 27, 2012 - 4:05pm - 303_A2.dwg
 H:\Heating Plant\Building Plan - Book Copy\

M MONTANA STATE UNIVERSITY
 FACILITIES PLANNING,
 DESIGN & CONSTRUCTION
 BOZEMAN, MONTANA
 PHONE: 406.994.4131 FAX: 406.994.6572

INDEX #	5
BUILDING #	303

Apr 27, 2012 - 4:05pm - 303_AR.dwg
H:\Heating Plant\Building Plan - Book Copy\

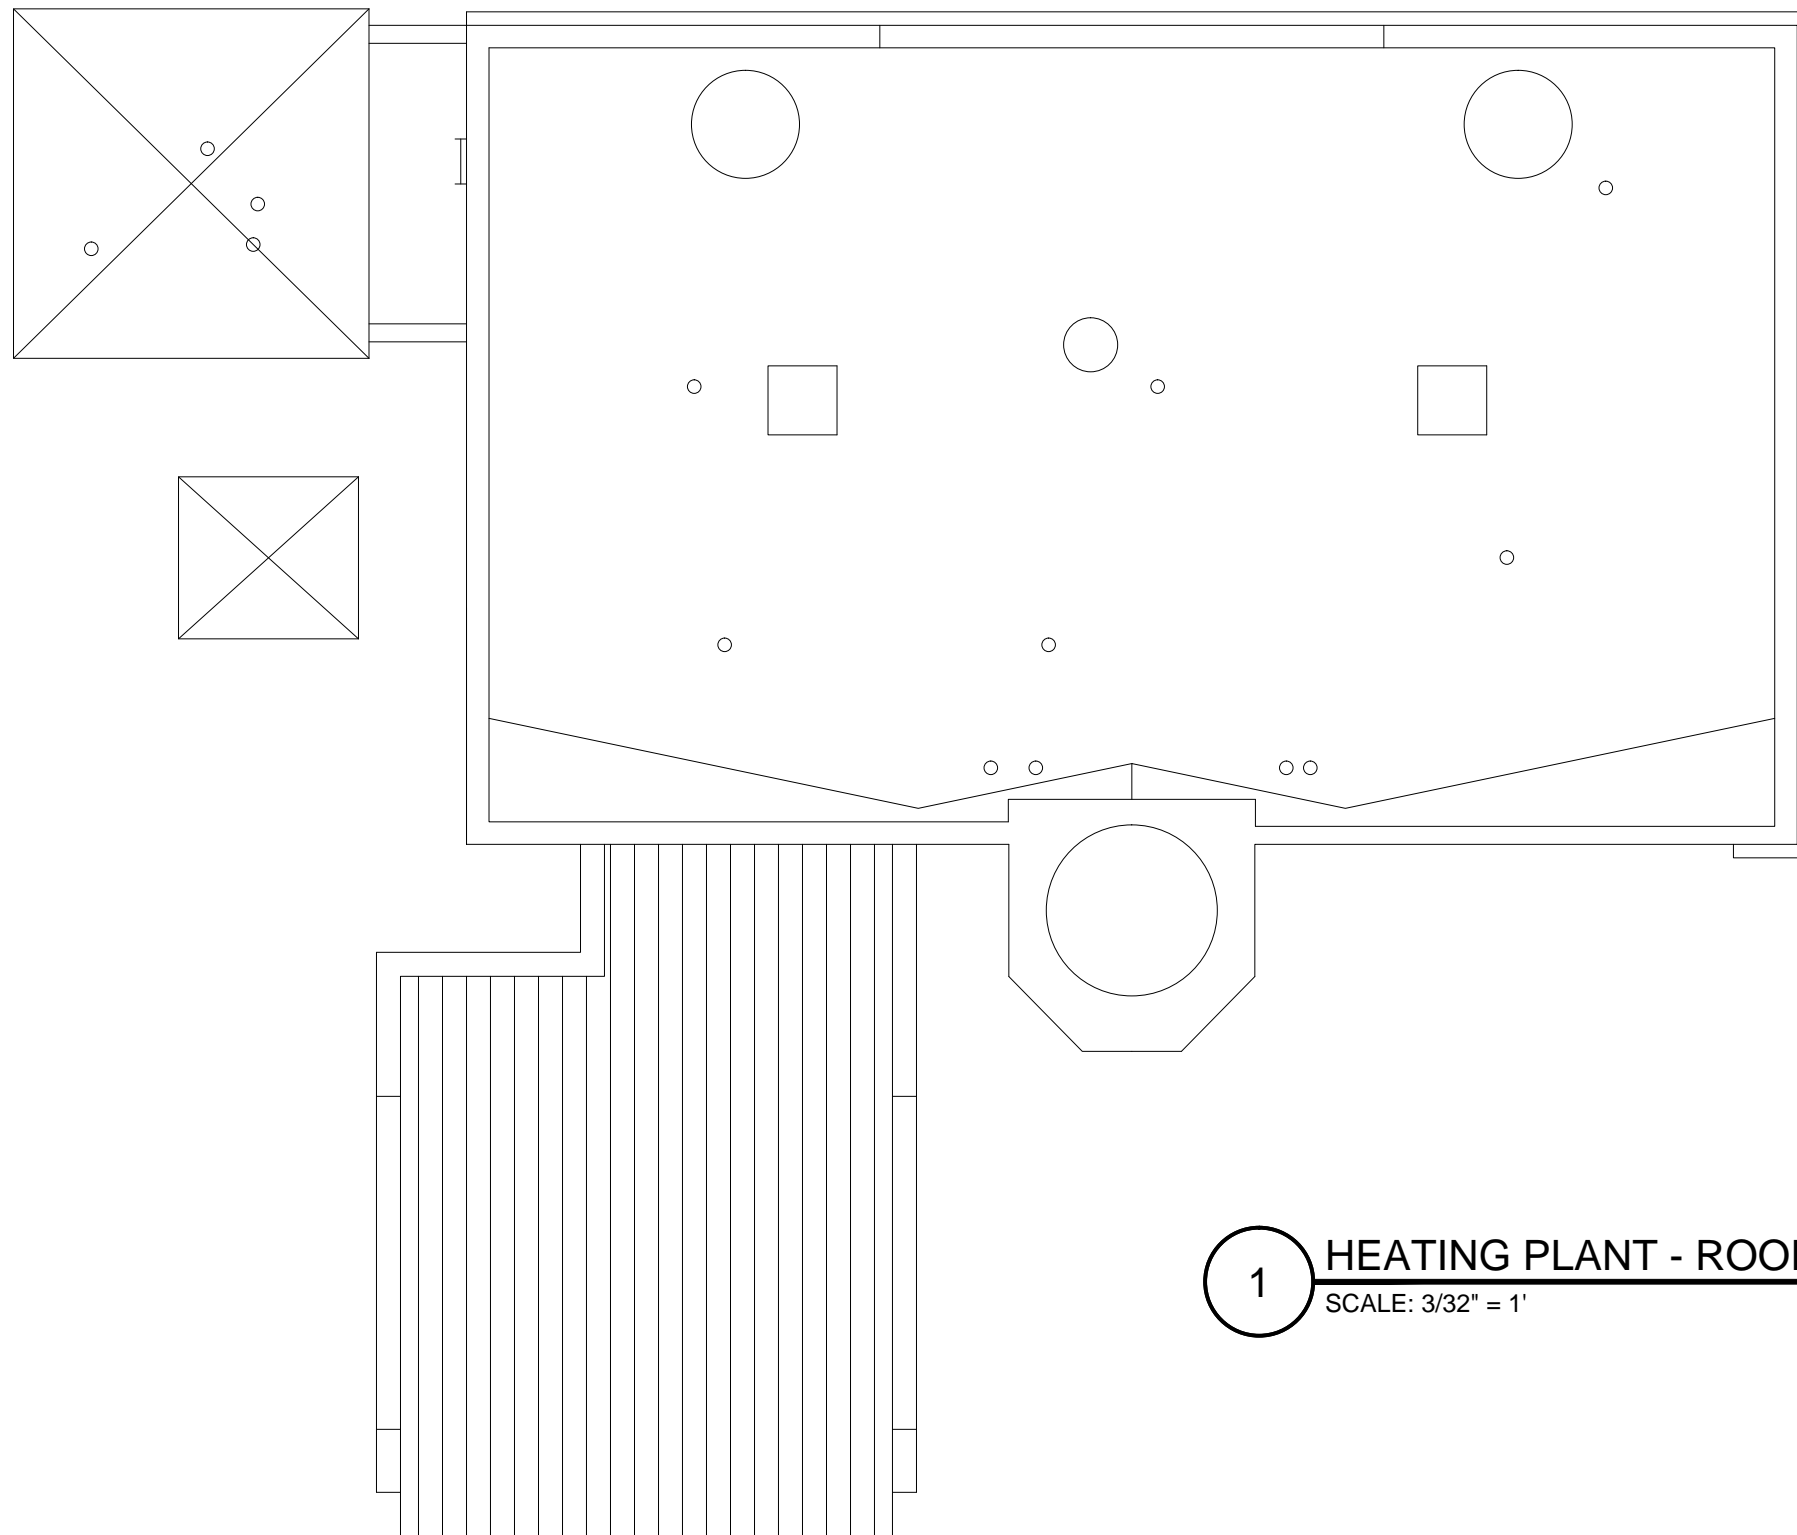

1

HEATING PLANT - ROOF LEVEL
SCALE: 3/32" = 1'



M MONTANA
STATE UNIVERSITY
FACILITIES PLANNING,
DESIGN & CONSTRUCTION
BOZEMAN, MONTANA
PHONE: 406.994.4131 FAX: 406.994.6572

INDEX #	5
BUILDING #	303